



Foundation plan

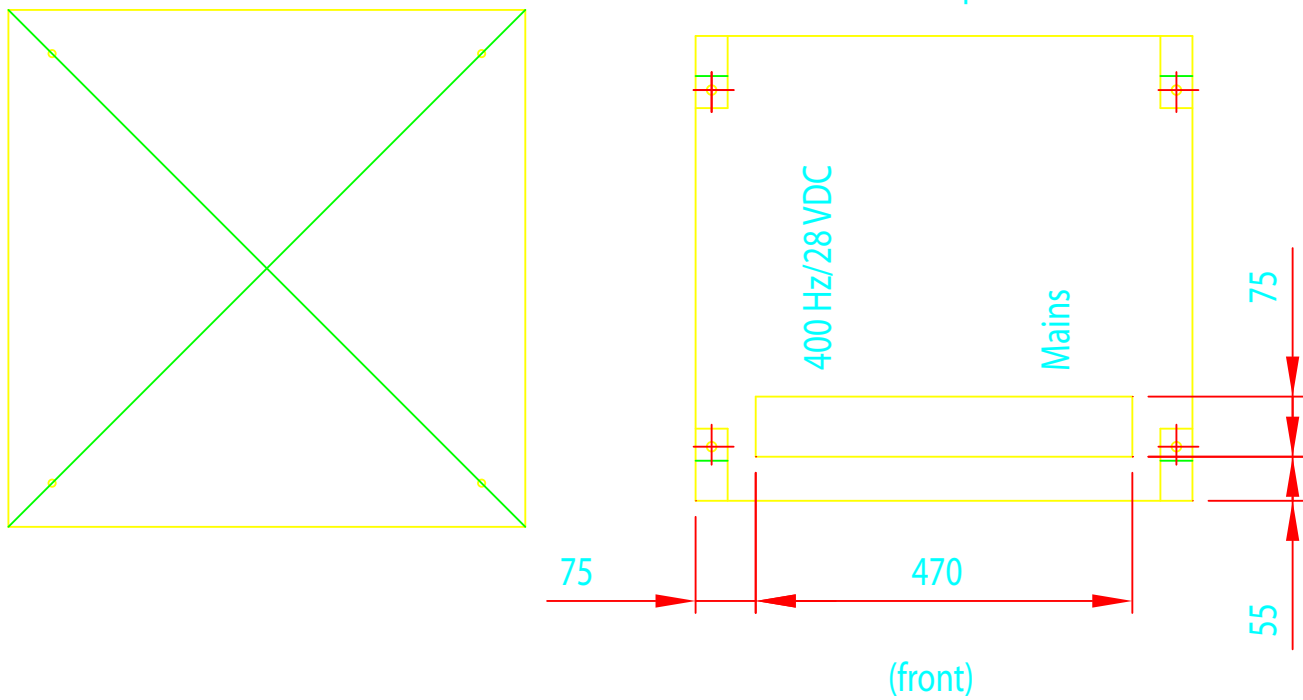

(front)

		Smedebakken 31-33 DK-5270 Odense N		Fixed configuration 7.5 - 15 kVA / 28 VDC GPU		Page: 1/1	
Type: AXA 2200, Mini				Outline Drawing			
Drawn: 220998 RH	Approved: SD	Scale: 1:10	(A4)	Revised: 030699/SD, 290803/	Rev.: B	Drg.no.: 173.075	